


We point out the minimum requirement of the foundation in our plans. The condition of the specific local situation (for example: ground under the foundation) does not lie our responsibility. If necessary an architect must be consulted.

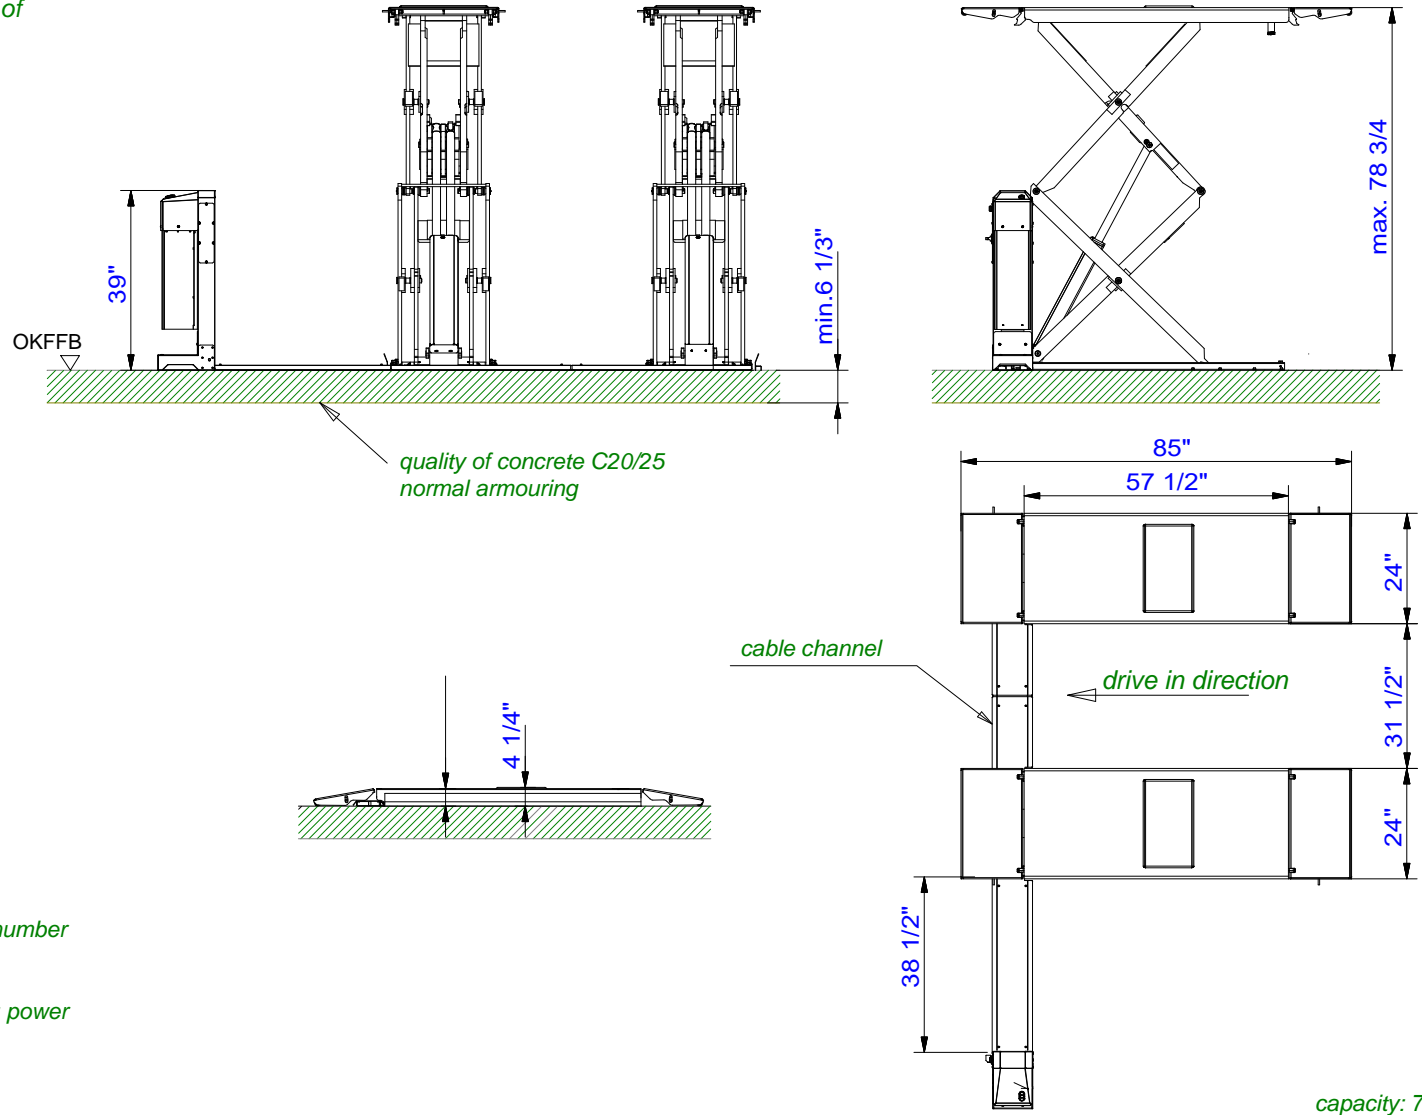

If ordering, the foundation plan or drawing number must be specified in the order

Prepared by customer at the operating unit: power supply: 230V, 60Hz fuse: 20 Ampere, time lag

Dimensions and design changes reserved!

(3D CAD-Modell)				Projektionsmethode 1 ISO 5456-2		Benennung / designation		
-	-	-	-	Datum	Name	<h1>Jumbo 7</h1> <p>Above ground</p>		
-	-	-	-	Bearb.	21.04.2015			MG
-	-	-	-	Gepr.				
-	-	-	-			Zeichnungsnummer / drawing number		
a	neues Design	19.10.22	MH			Korker Straße 24, 77694 Kehl www.nussbaumlifts.com		<h2>7757_NB_USA</h2>
ind.	Aender. / modification	Datum	Name					